


6	SEPT./15	FIRE ALARM SYSTEM REPLACEMENT
5	SEPT./14	FIREPLAN UPDATE
4	MAY/08	FMIS UPDATE
3	AUG./04	FMIS UPDATE
2	NOV. /00	FMIS UPDATE
1	NOV. /99	FMIS UPDATE

REVISIONS		
NO.	DATE	DESCRIPTION
DRAWN BY	VM	SCALE N.T.S.
CH'D BY		DWG.No.
DATE	SEPT/07	C202-1




**GROUND FLOOR PLAN  
AURORA HIGH SCHOOL**

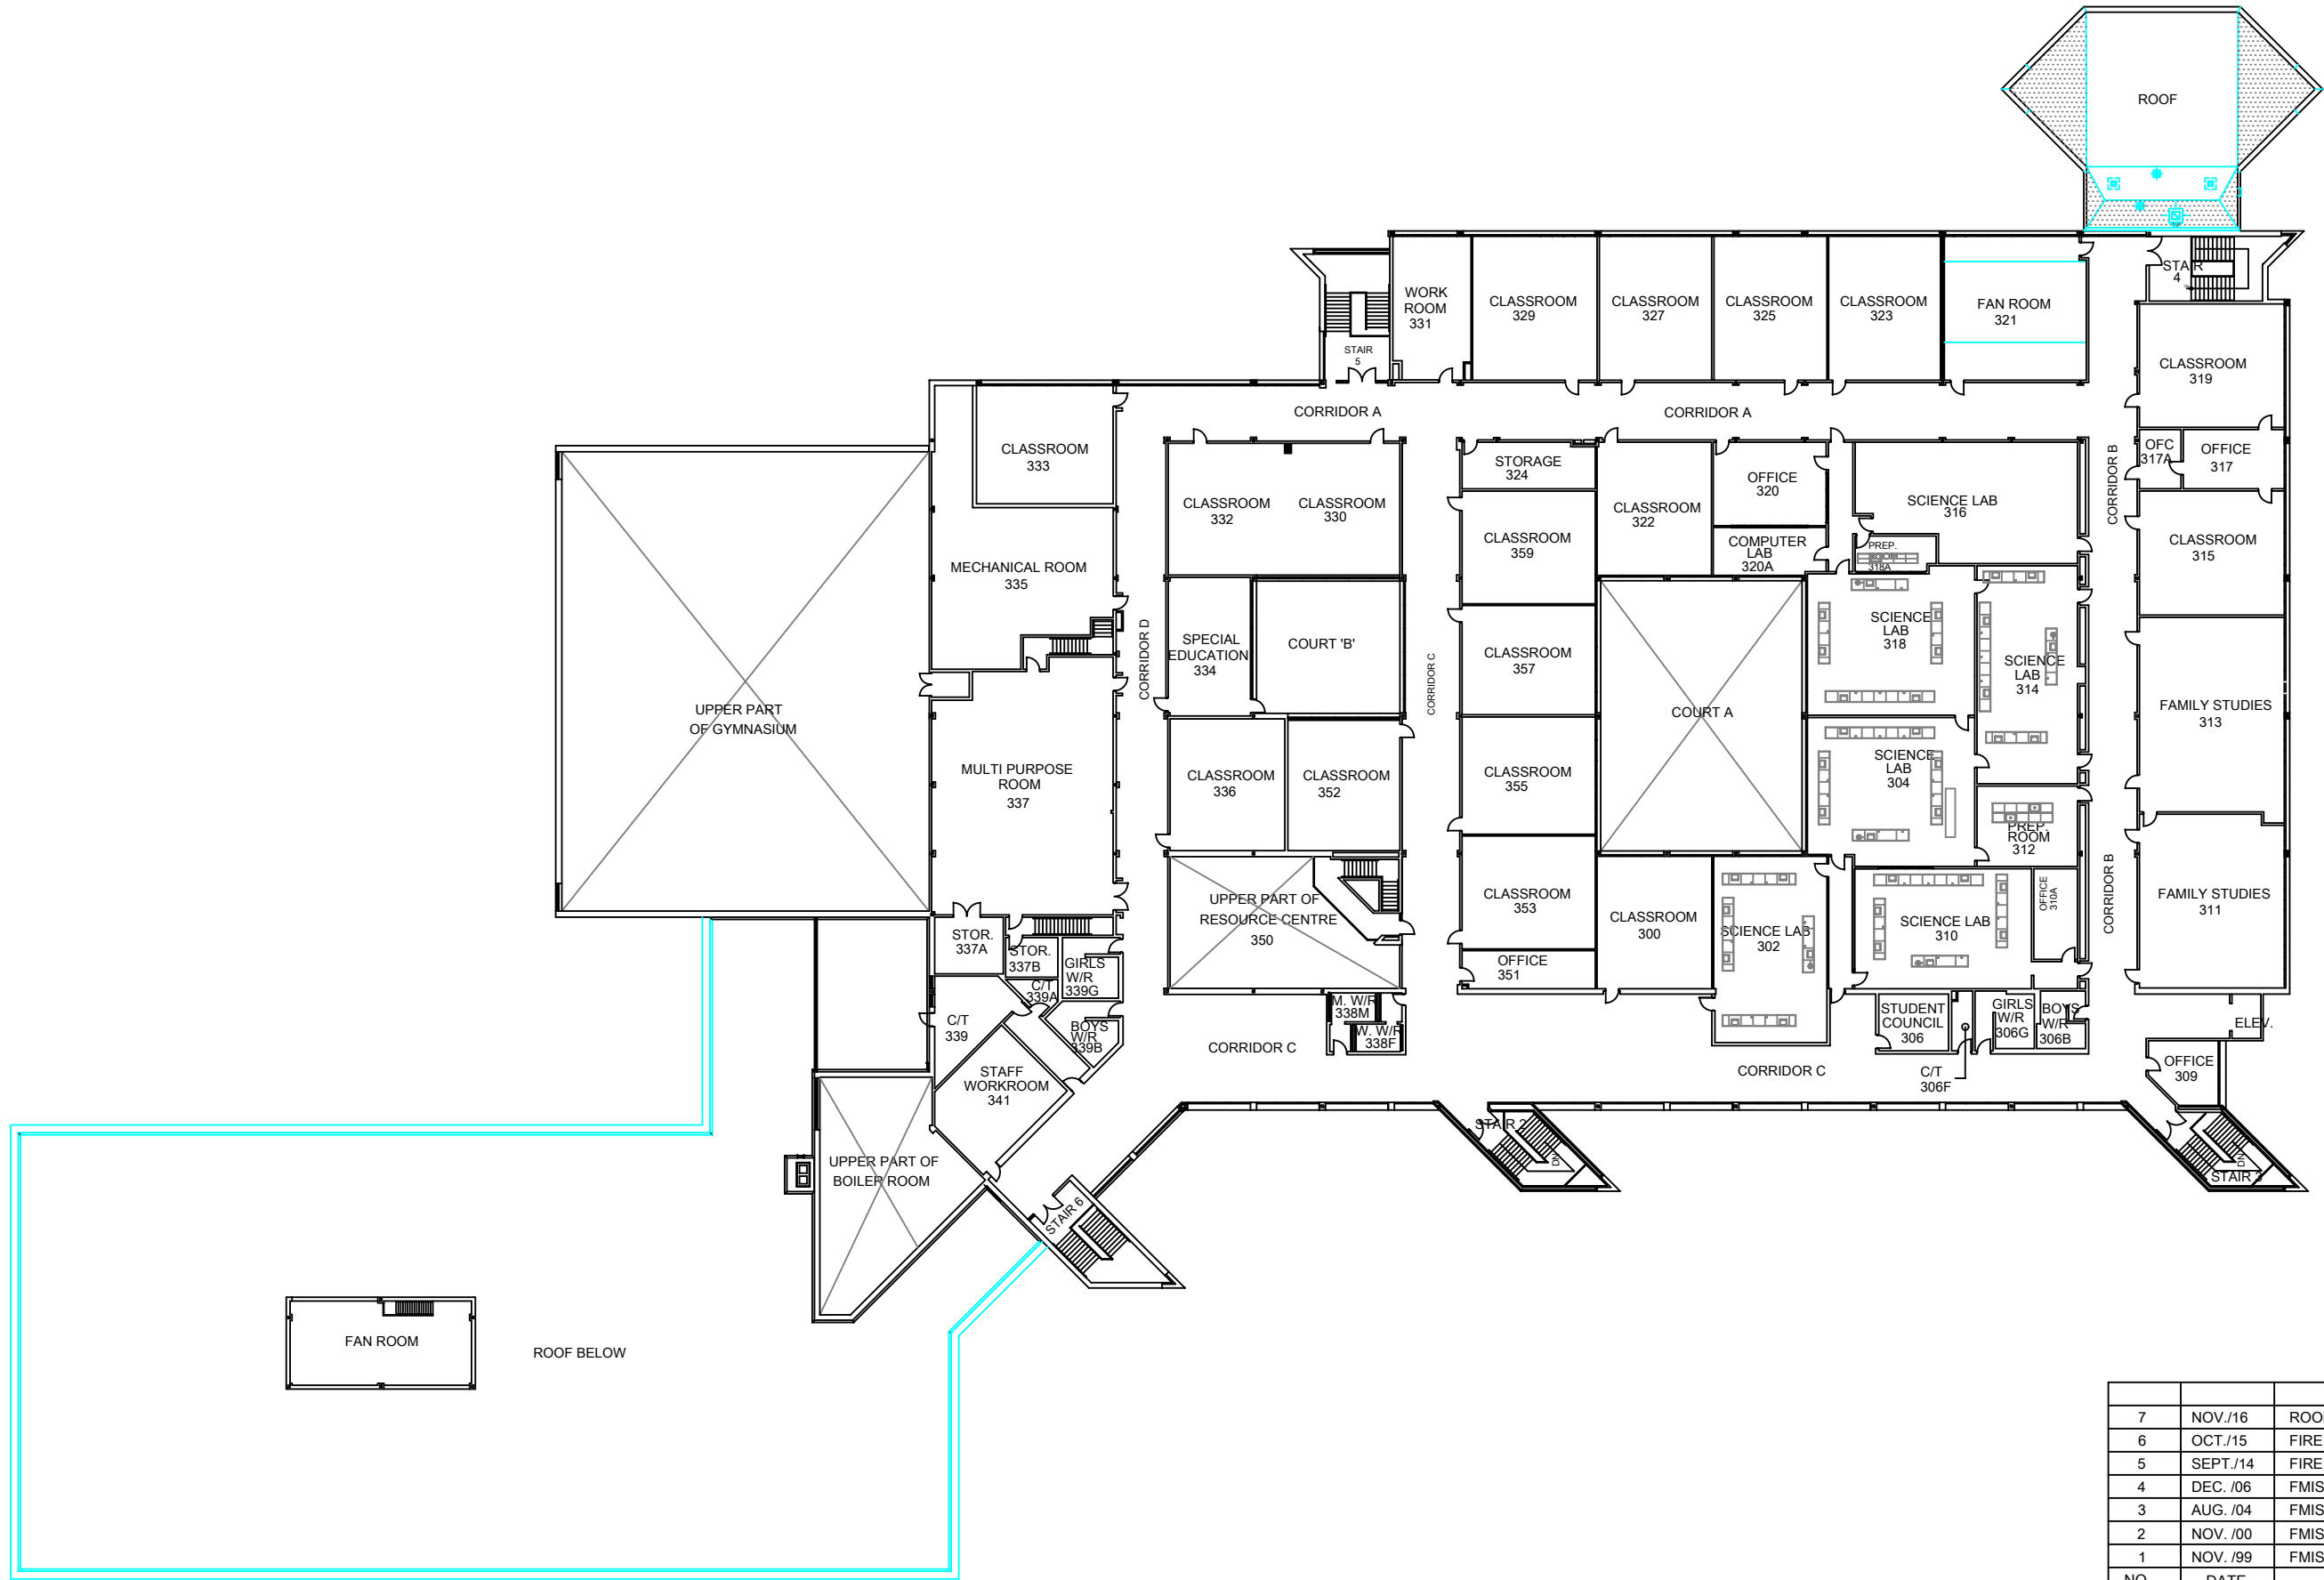


NO.	DATE	DESCRIPTION
7	NOV./16	ROOM NUMBER CHANGE (#S 316/318)
6	OCT./15	FIRE ALARM SYTEM REPLACEMENT
5	SEPT./14	FIREPLAN UPDATE
4	DEC. /06	FMIS UPDATE
3	AUG. /04	FMIS UPDATE
2	NOV. /00	FMIS UPDATE
1	NOV. /99	FMIS UPDATE

REVISIONS		
DRAWN BY	VM	SCALE N.T.S.
CH'D BY		DWG.No.
DATE	SEPT/07	C202-2

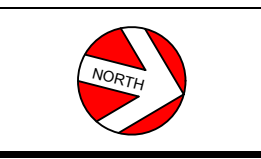

**SECOND FLOOR PLAN  
AURORA HIGH SCHOOL**

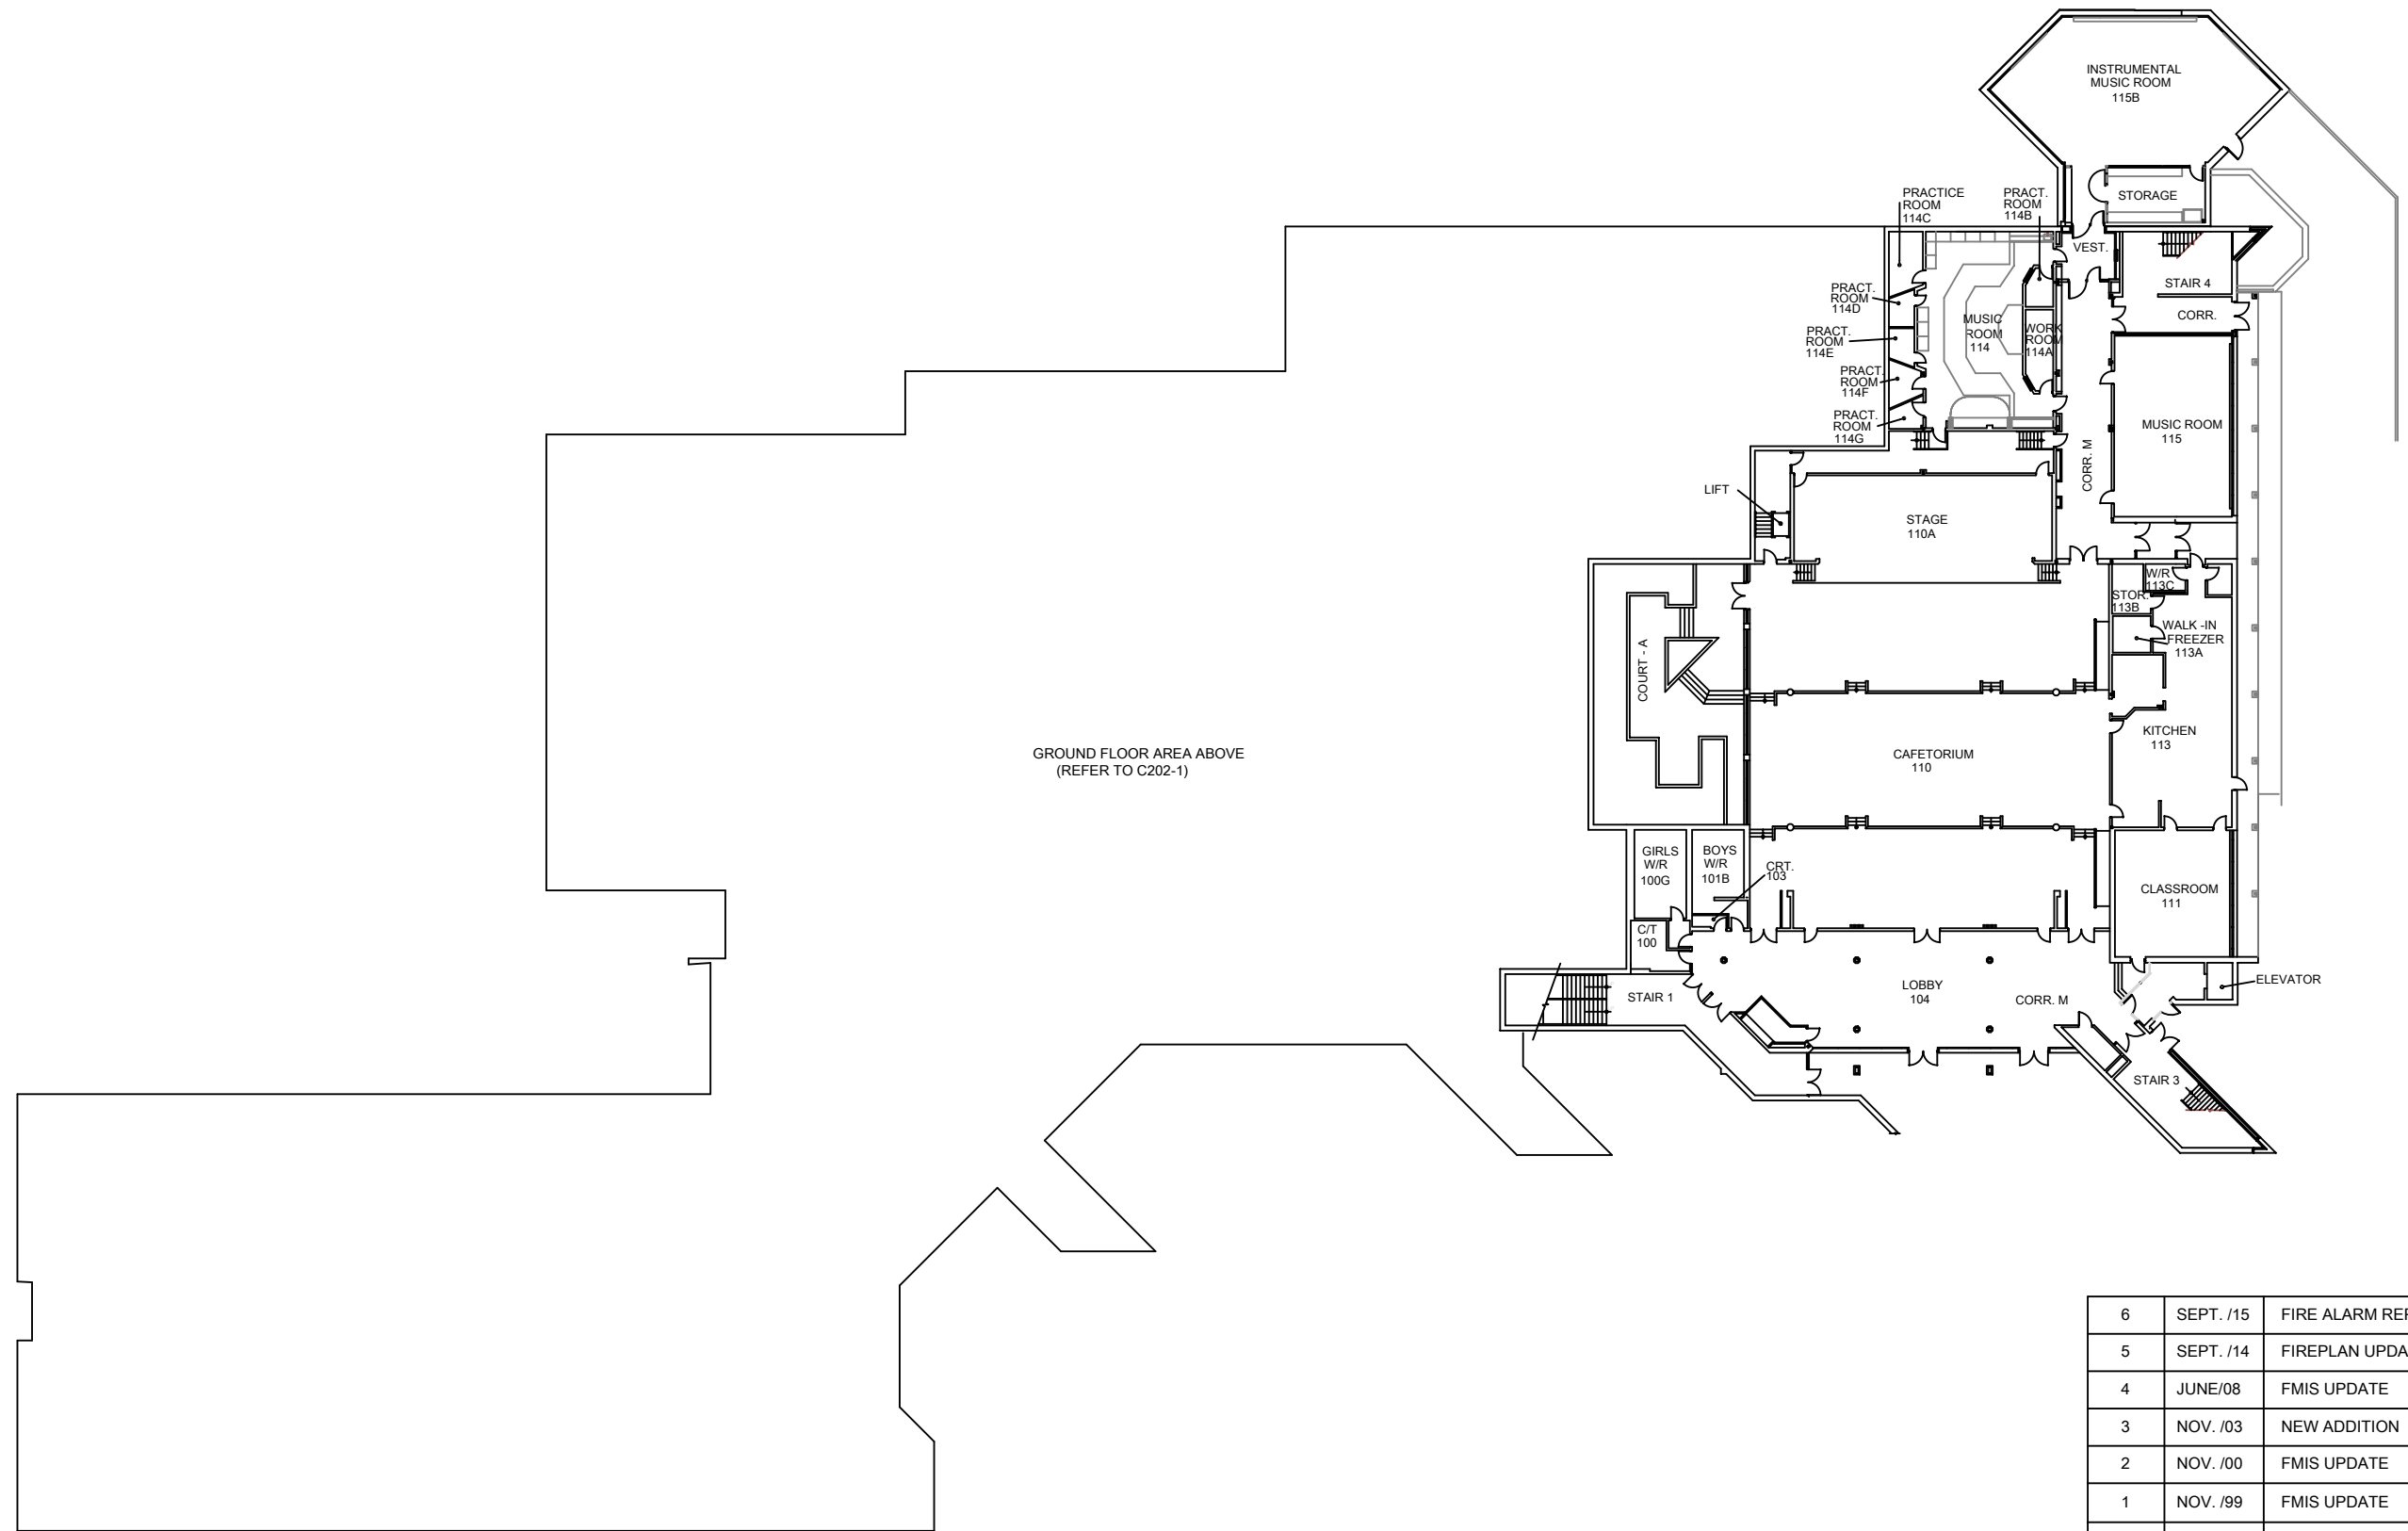

GROUND FLOOR AREA ABOVE  
(REFER TO C202-1)

6	SEPT. /15	FIRE ALARM REPLACEMENT
5	SEPT. /14	FIREPLAN UPDATE
4	JUNE/08	FMIS UPDATE
3	NOV. /03	NEW ADDITION
2	NOV. /00	FMIS UPDATE
1	NOV. /99	FMIS UPDATE

NO.	DATE	DESCRIPTION
REVISIONS		
DRAWN BY	JF	SCALE N.T.S.
CH'D BY	JF	DWG.No.
DATE	NOV. /00	C202-L



LOWER FLOOR PLAN  
AURORA HIGH SCHOOL